


| CFM SCHEDULE | |
|--------------|-----|
| MARK | CFM |
| A | 25 |
| B | 50 |
| C | 75 |
| D | 100 |
| E | 125 |
| F | 150 |
| G | 175 |
| H | 200 |
| J | 225 |
| K | 250 |
| L | 275 |
| M | 300 |
| N | 325 |
| P | 350 |
| R | 375 |
| S | 400 |
| T | 425 |
| U | 450 |
| V | 475 |
| W | 500 |

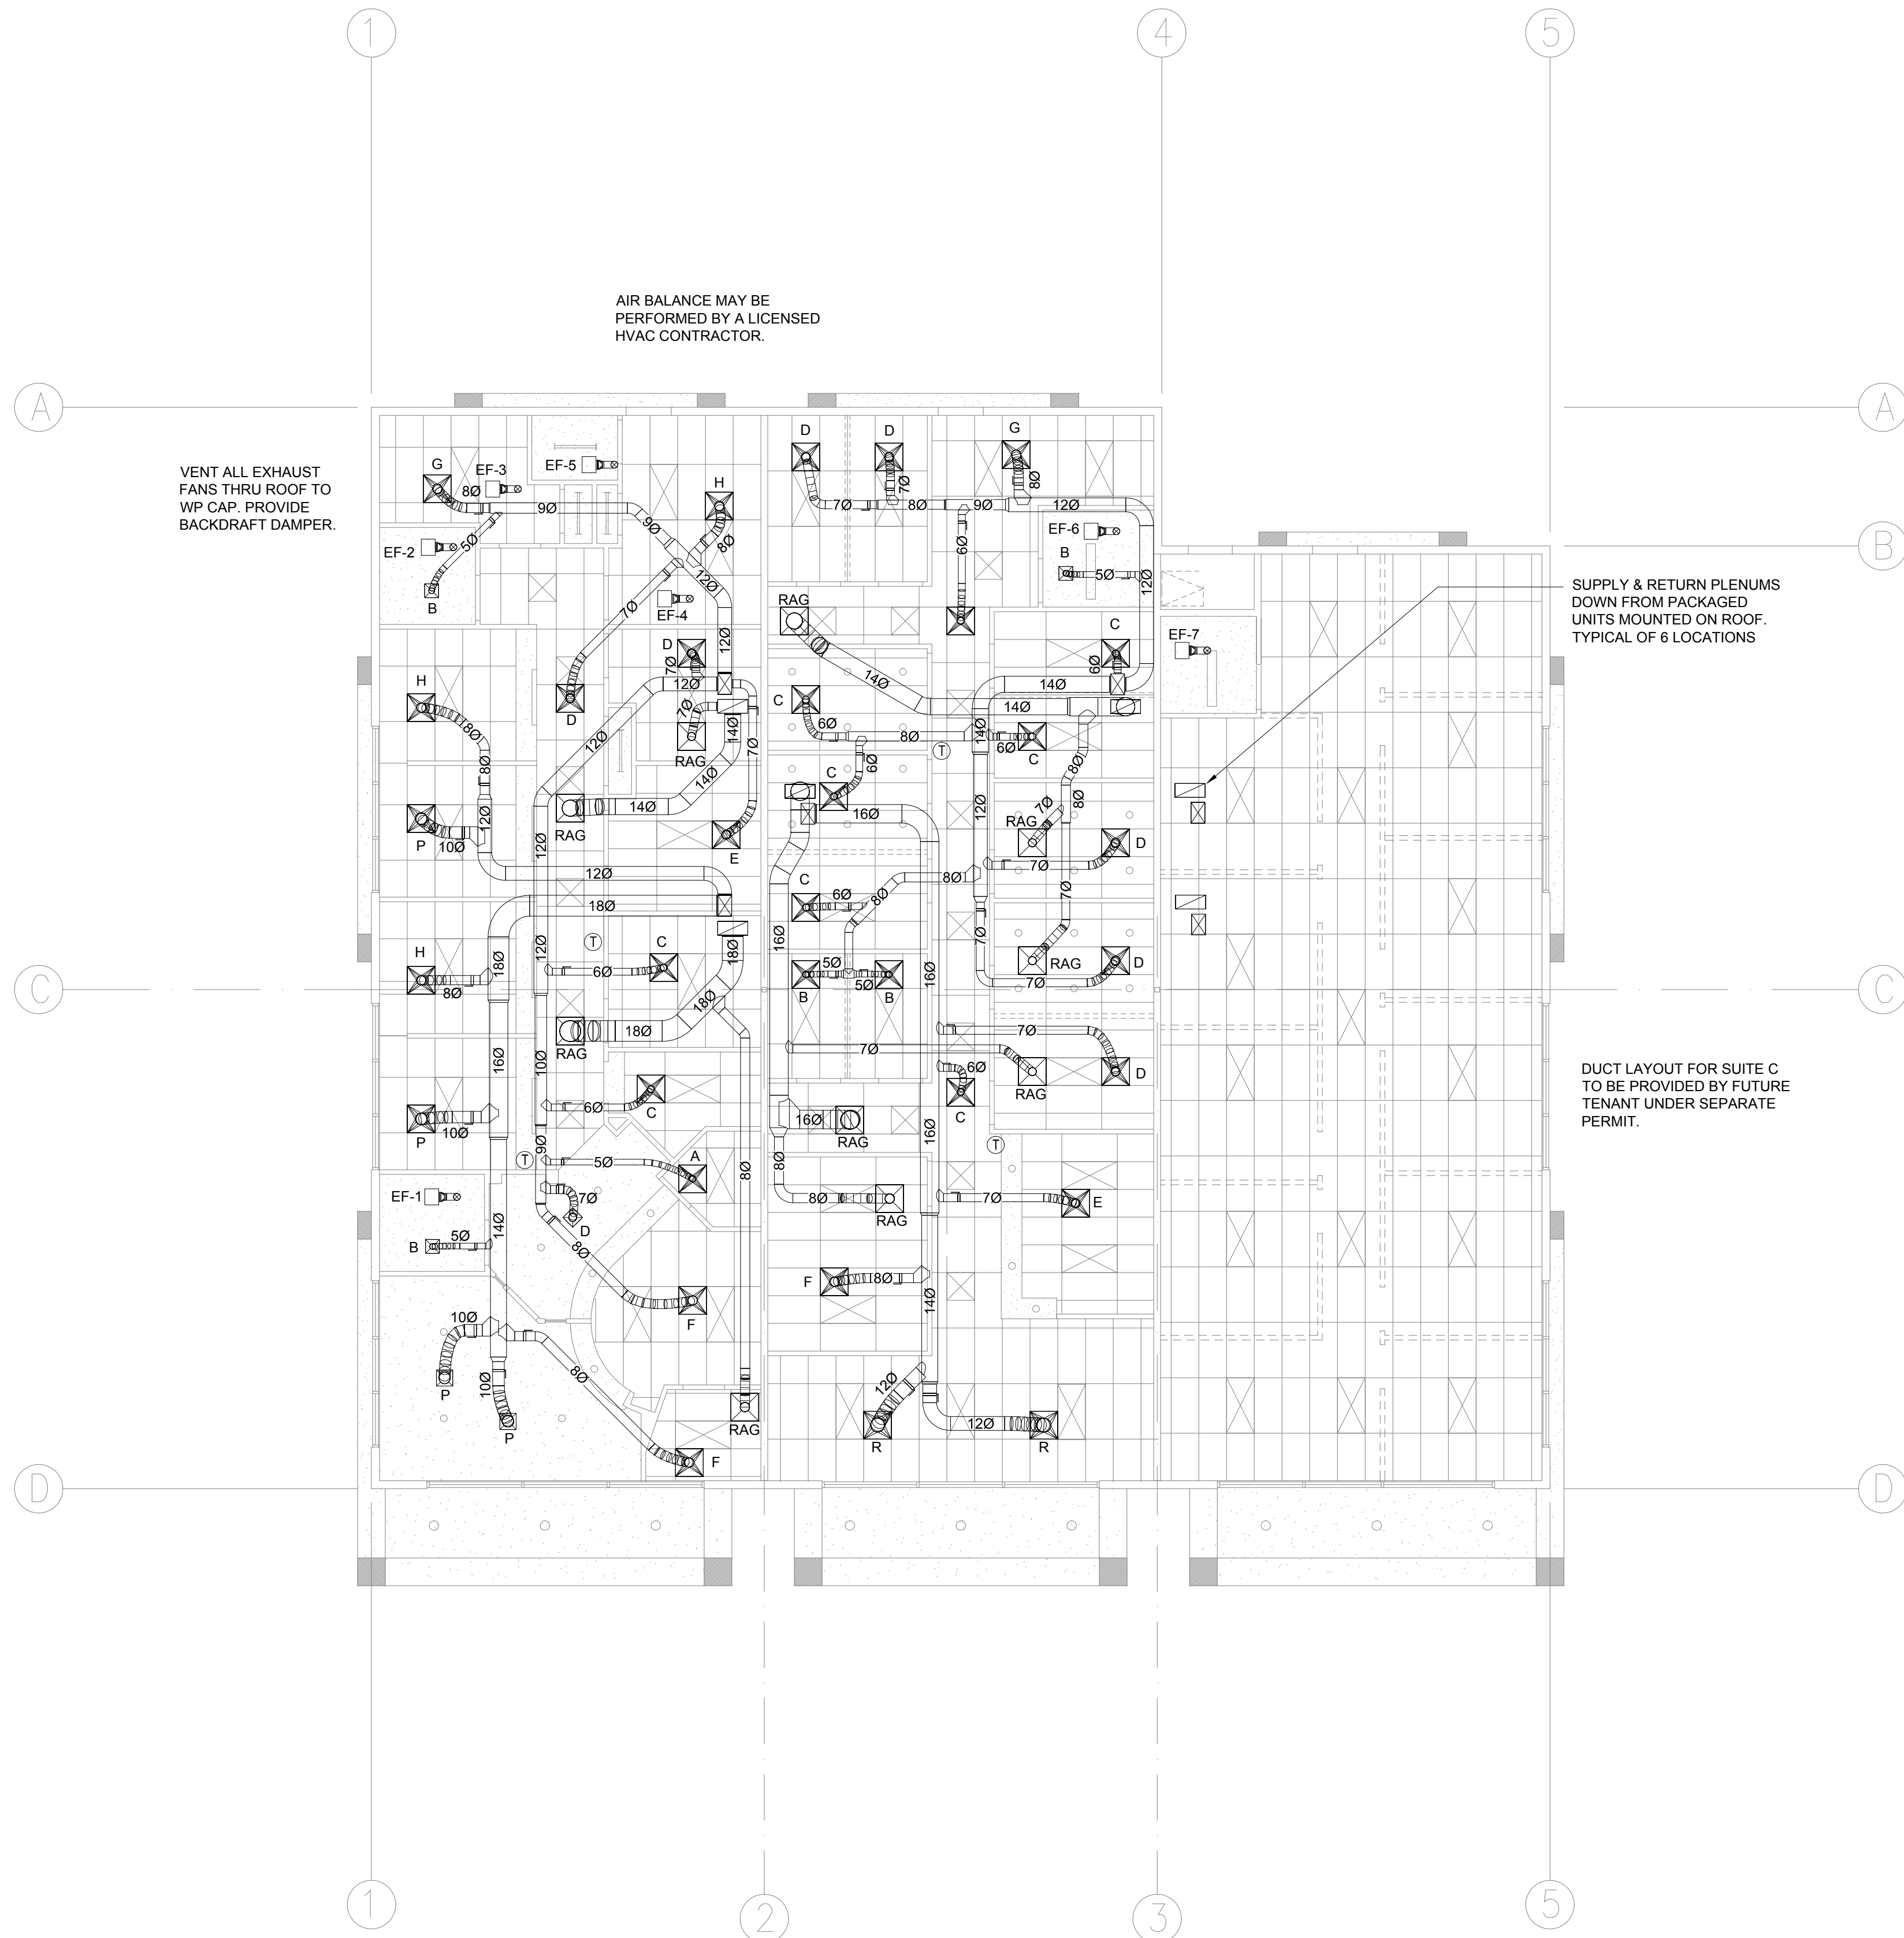


HVAC PLAN

SCALE: 1/8" = 1'-0" **1**

| NO. | REVISION | BY | DATE |
|-----|----------|----|------|
| | | | |
| | | | |
| | | | |

HANDLEY ENGINEERING
 130 EL CAMINO REAL, TUSTIN, CA 92780
 SUITE 200 (714) 669-1141

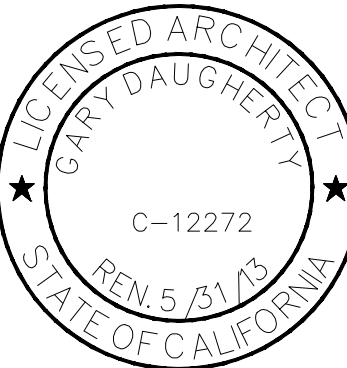

SOUTHLAND
 energy consultants
 1110 24th St., Suite 100, Laguna Beach, CA 92651
 HVAC, plumbing and electrical design
 PH: 949/497-3210 FAX: 949/497-3591
 Email Address: pekland@aol.com

NEW PROFESSIONAL OFFICE FOR:
JAMES HOCH, D.D.S.
 32246 CLINTON KEITH ROAD, WILDOMAR, CA 92595

DATE: 11.28.11
 JOB NO: TM/SL/JH
 DRAWN: PK
 CHECKED: GD/PK
 SCALE: AS NOTED
 SHEET

M2.0
 OF SHEETS