



**3 NATURAL GAS RISER**  
SCALE: NOT TO SCALE

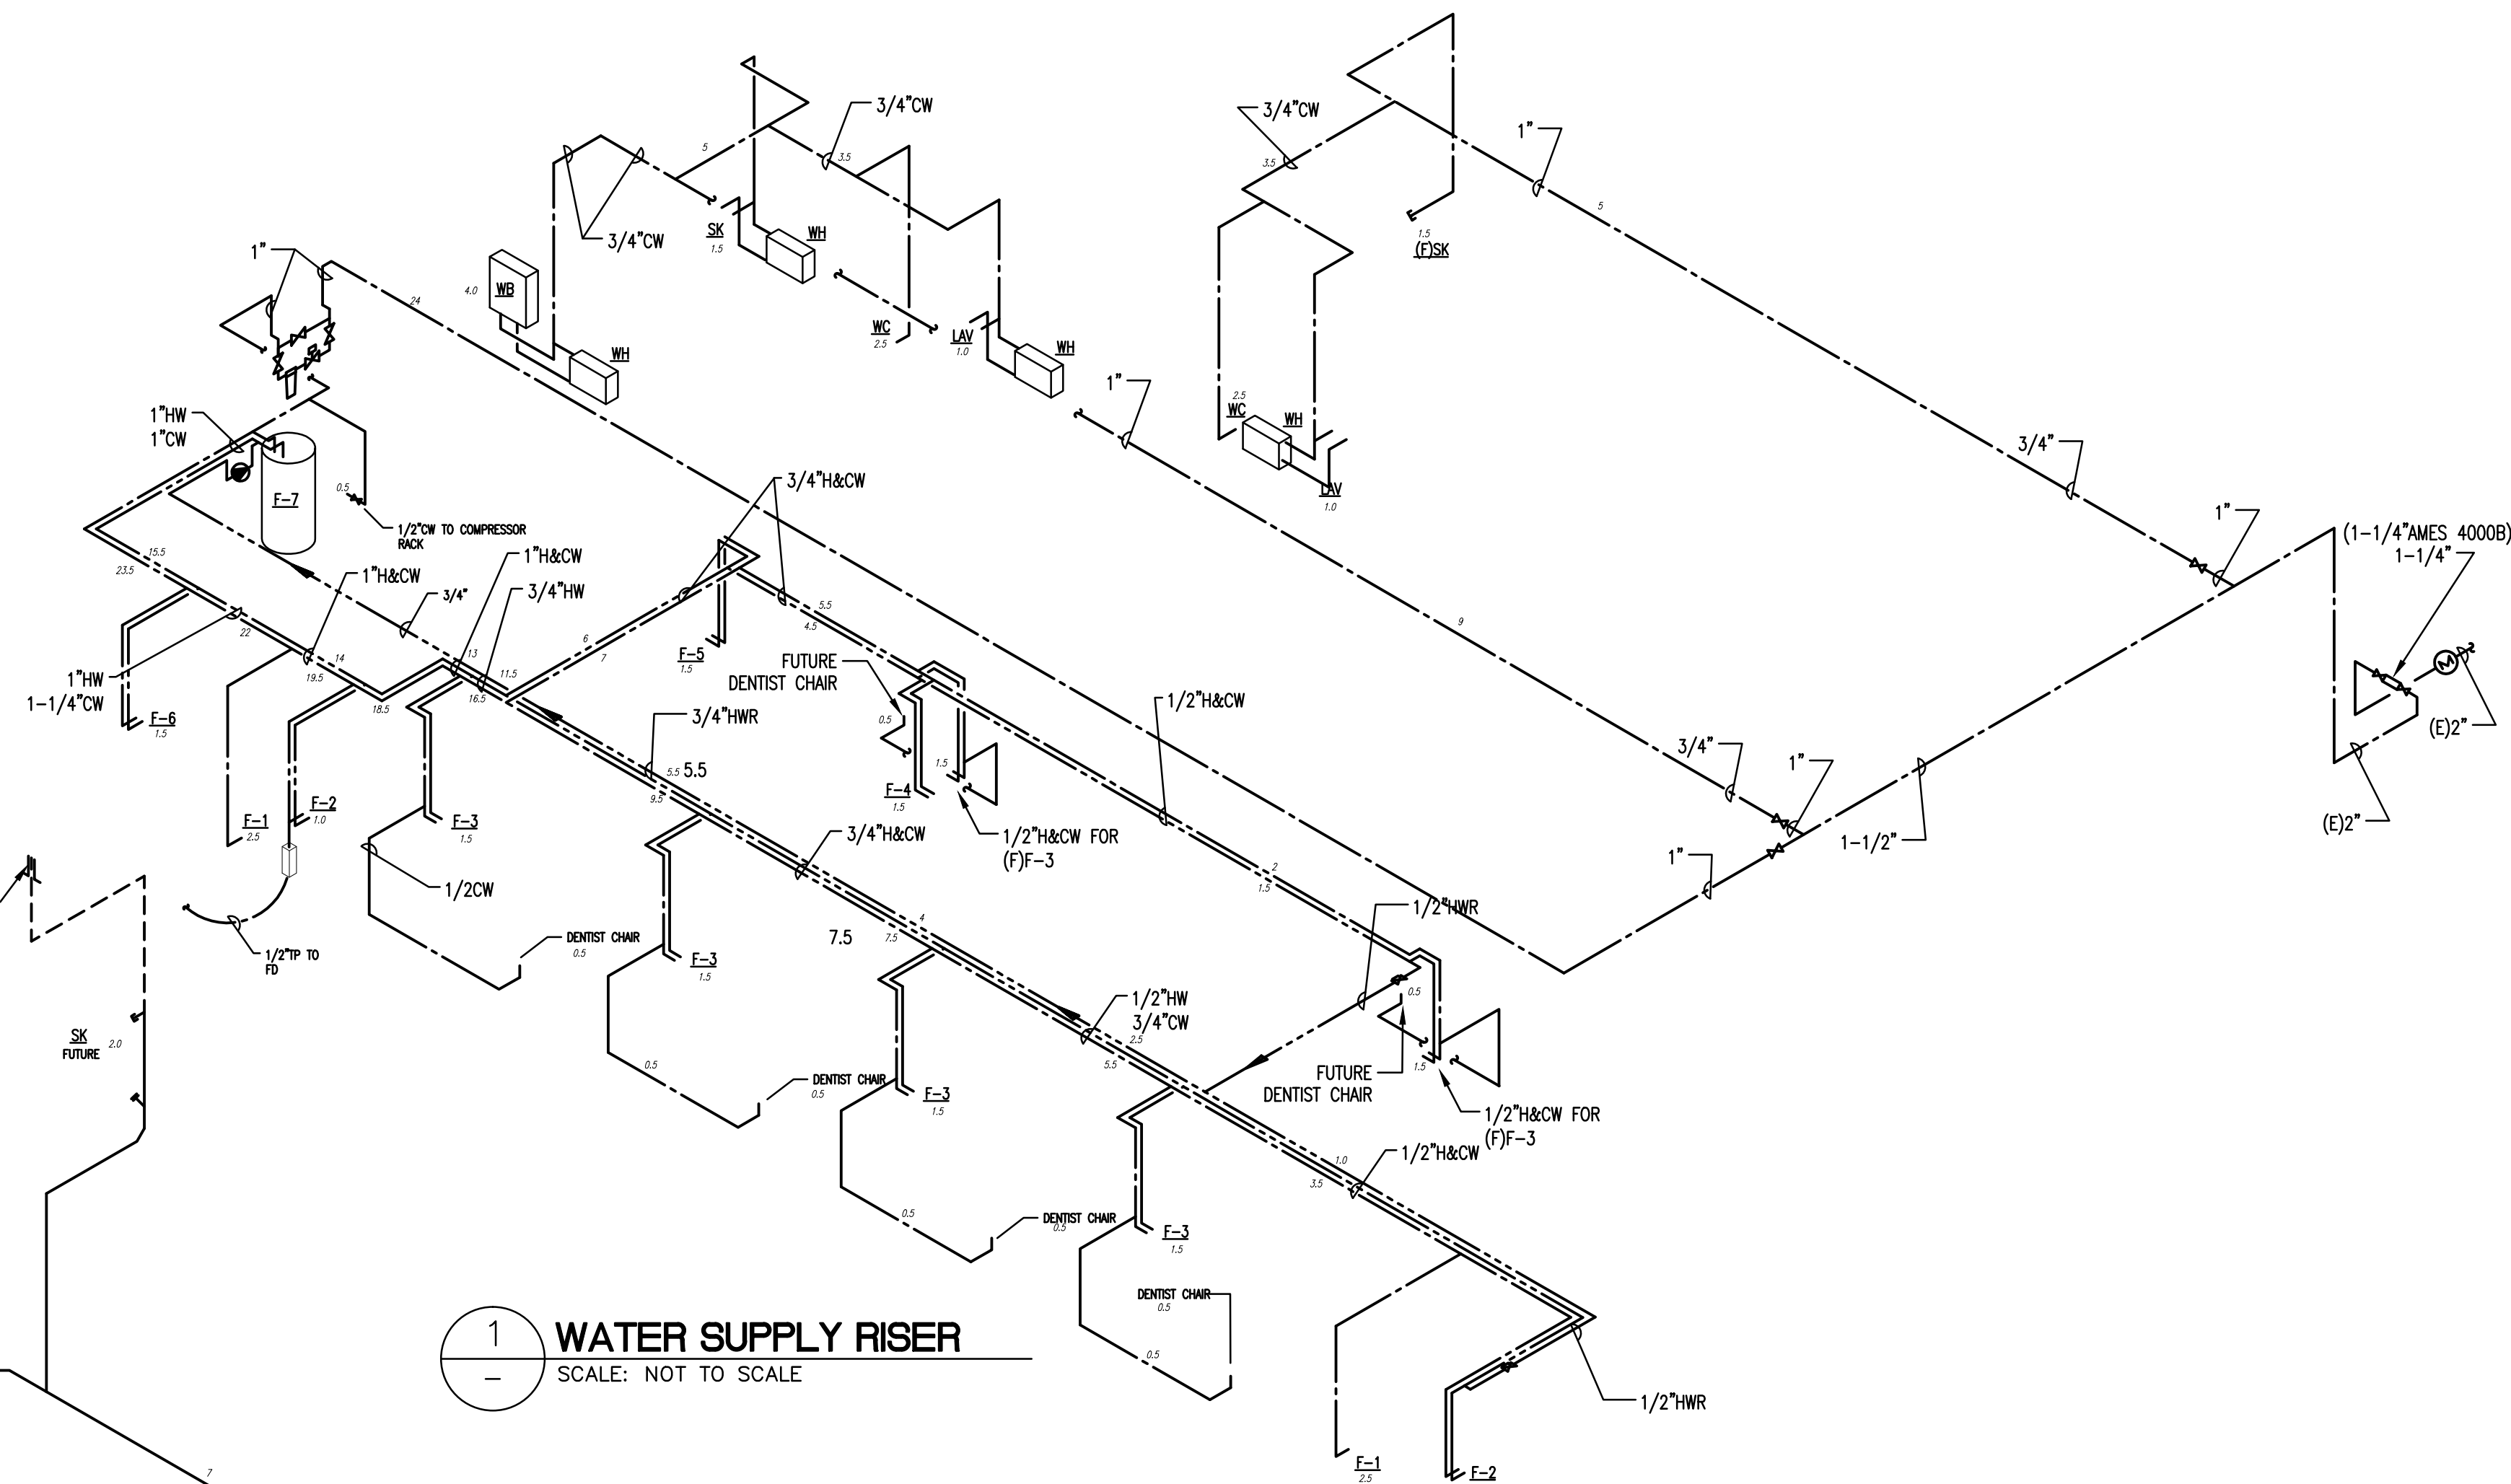

**1 WATER SUPPLY RISER**  
SCALE: NOT TO SCALE

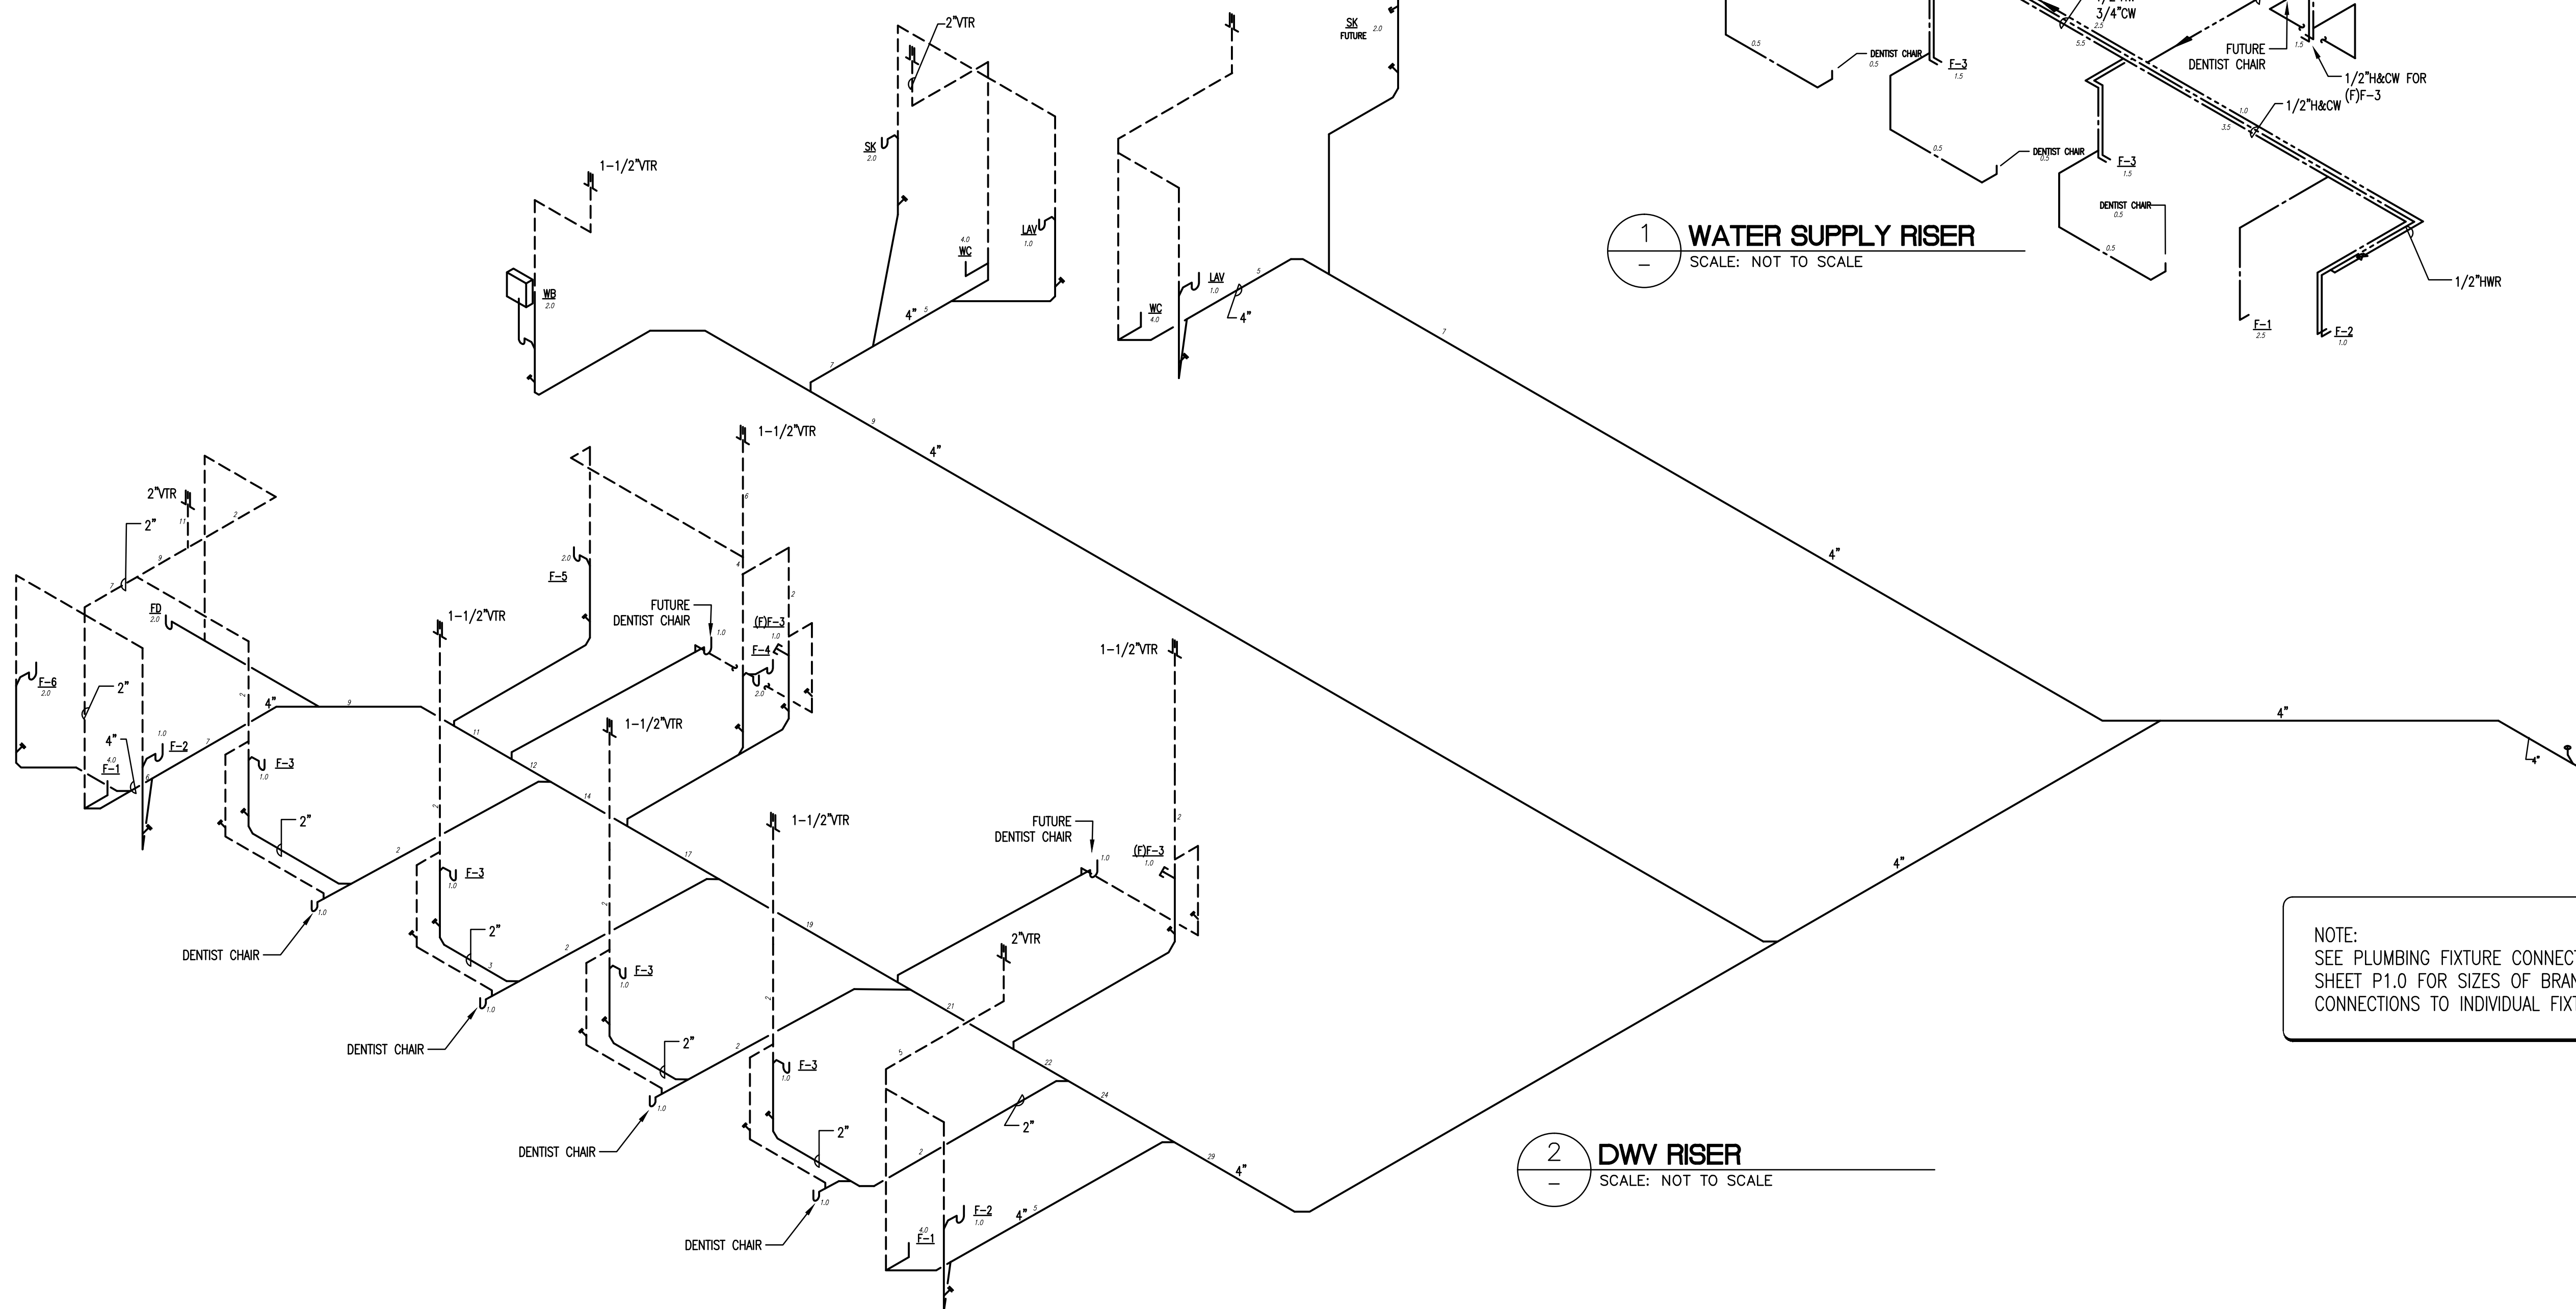

**2 DWV RISER**  
SCALE: NOT TO SCALE

NOTE:  
SEE PLUMBING FIXTURE CONNECTION CHART ON  
SHEET P1.0 FOR SIZES OF BRANCH  
CONNECTIONS TO INDIVIDUAL FIXTURES.

NO.	REVISION	BY	DATE

**HANDLEY ENGINEERING**  
130 EL CAMINO REAL, TUSTIN, CA 92780  
SUITE 200 (714) 669-1141



**SOUTHLAND**  
energy consultants  
1110 S. 24th St., Suite 100  
Fresno, CA 93721  
1481 Glenview St., Laguna Beach, CA 92651  
PH: 949/497-3591 FAX: 949/497-3210  
Email Address: pekland@aol.com

NEW PROFESSIONAL OFFICE FOR:  
**JAMES HOCH, D.D.S.**  
32246 CLINTON KEITH ROAD, WILDOMAR, CA 92595

DATE: 12.06.11  
JOB NO: H11-135  
DRAWN: JH  
CHECKED: JH  
SCALE: AS NOTED  
SHEET

**P3.0**  
OF SHEETS